




Eldridge Street
Synagogue

Interior Restoration
Lighting


Eldridge Street Project
12 Eldridge Street
New York, NY 10002

ISSUED FOR BID

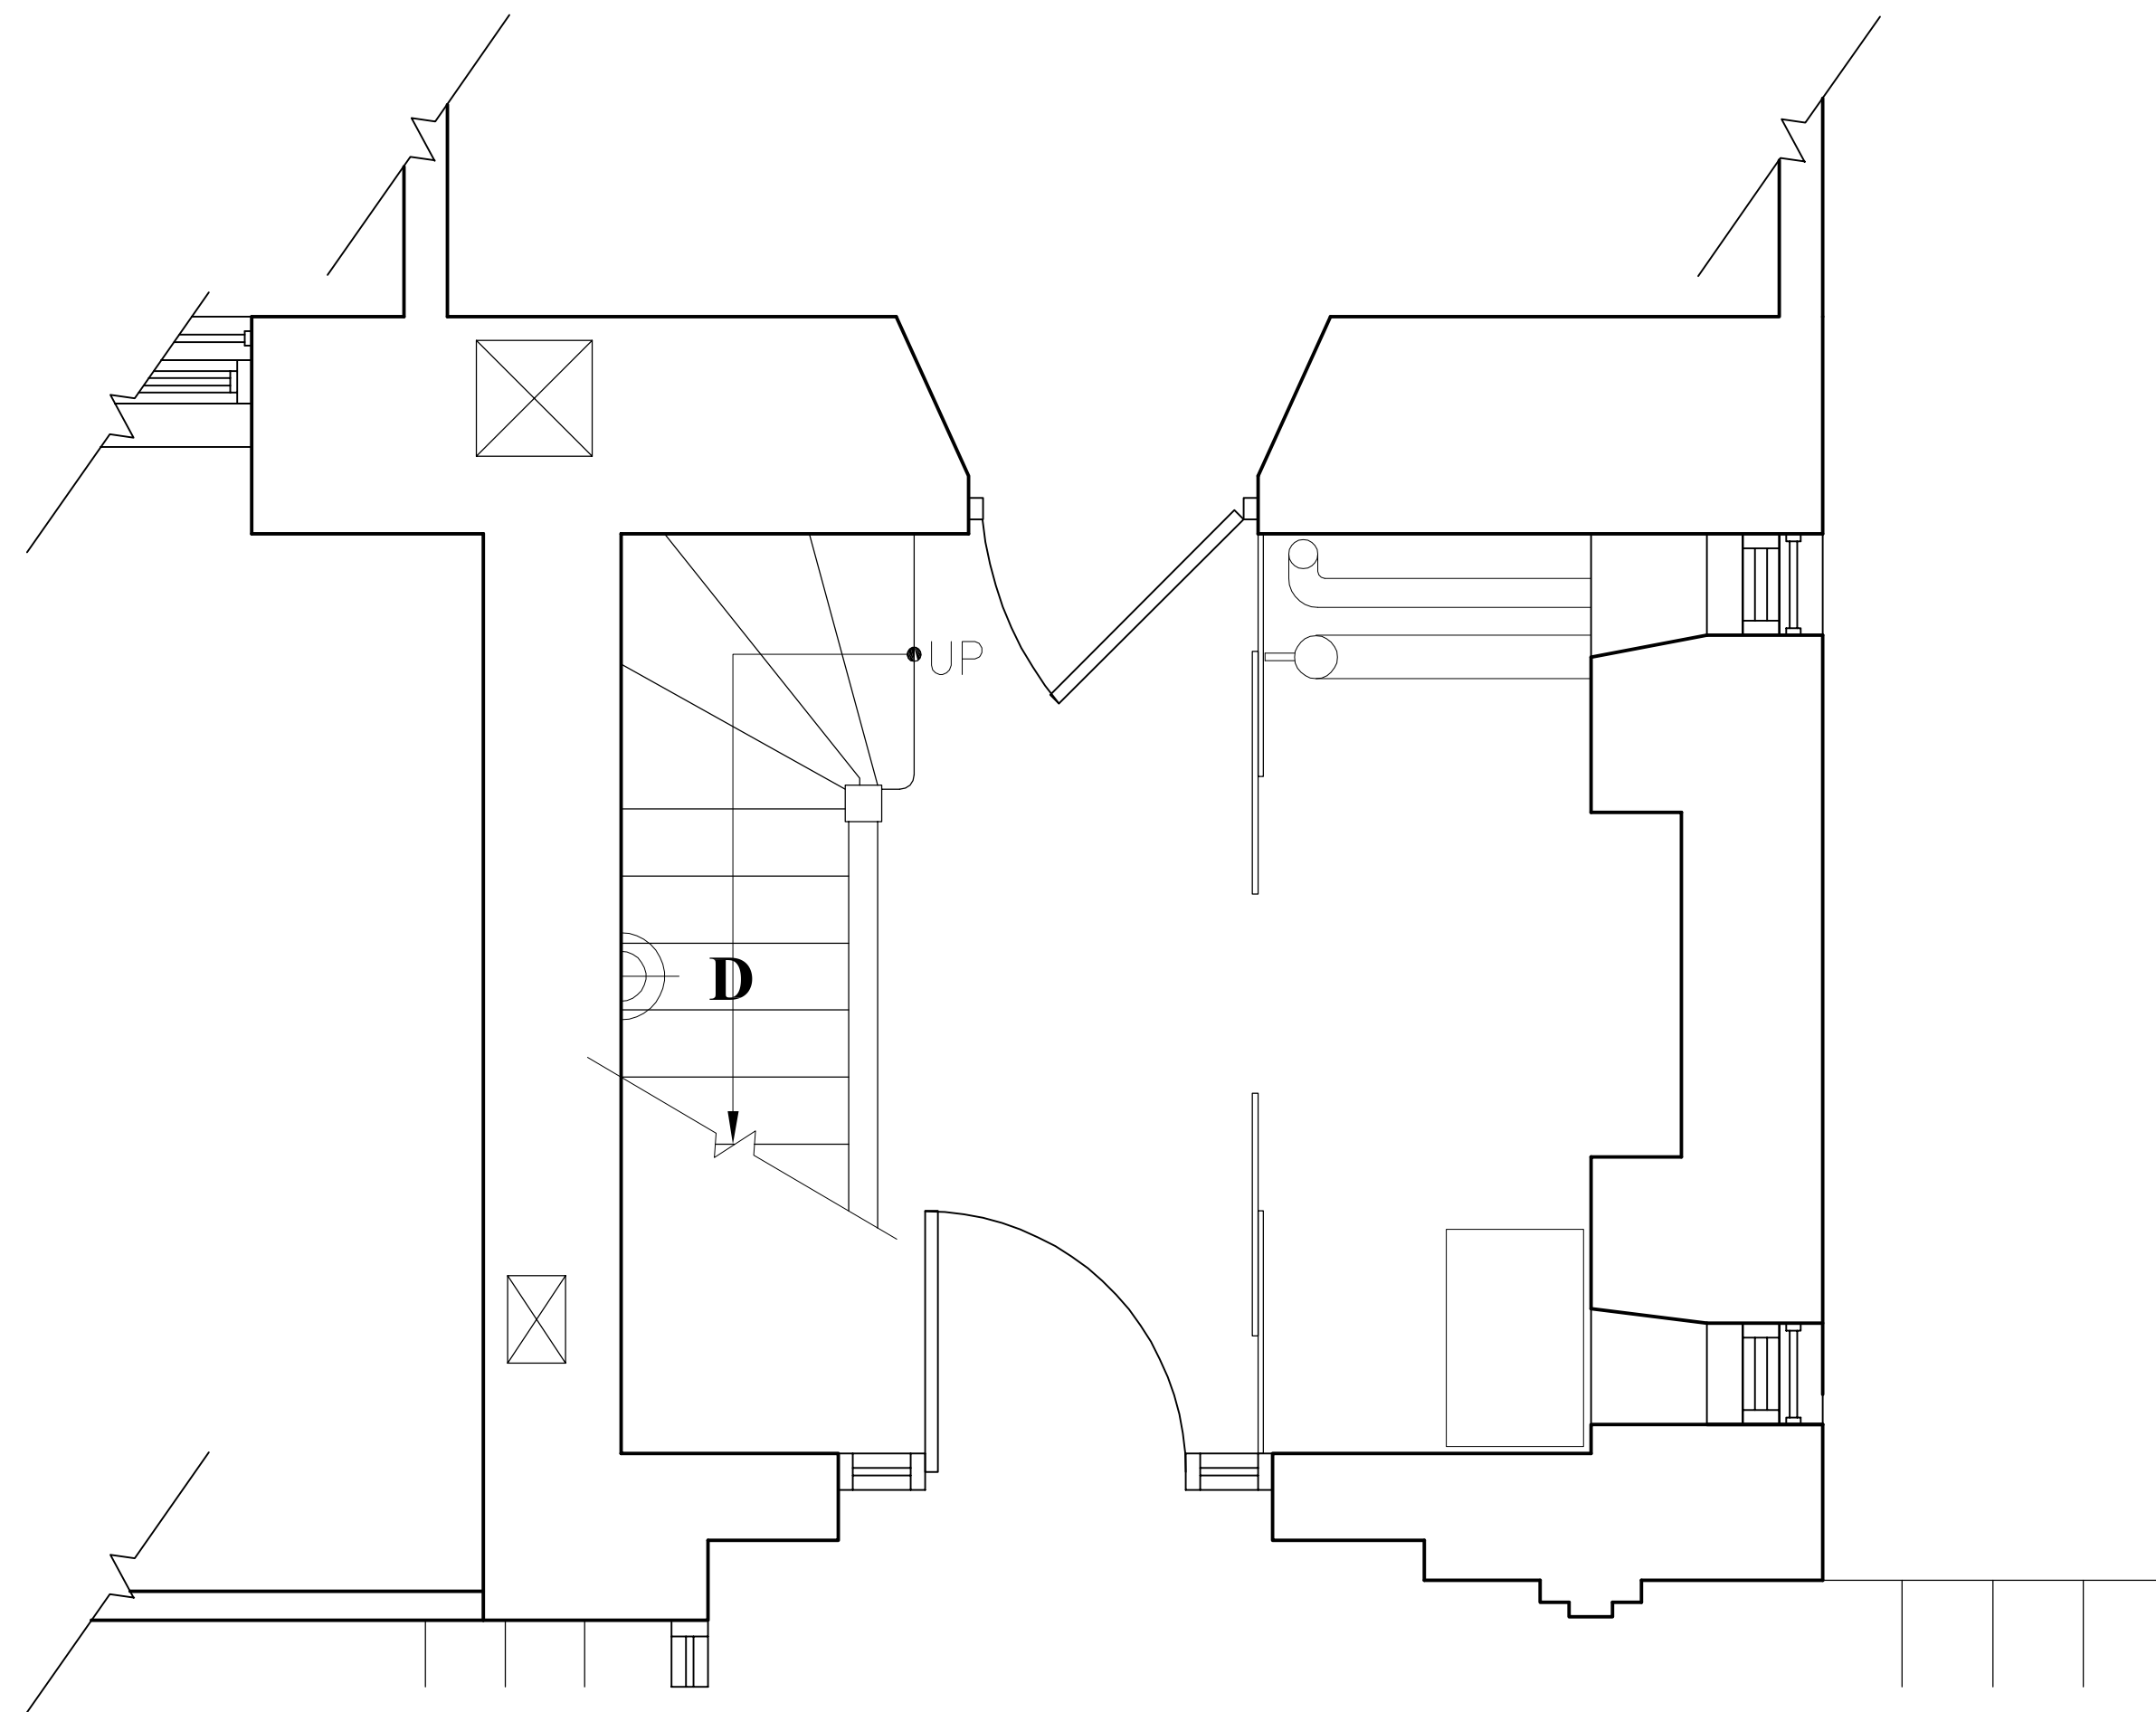


Stair Plan @ Street Level

SCALE:
1/2" = 1'-0" 1

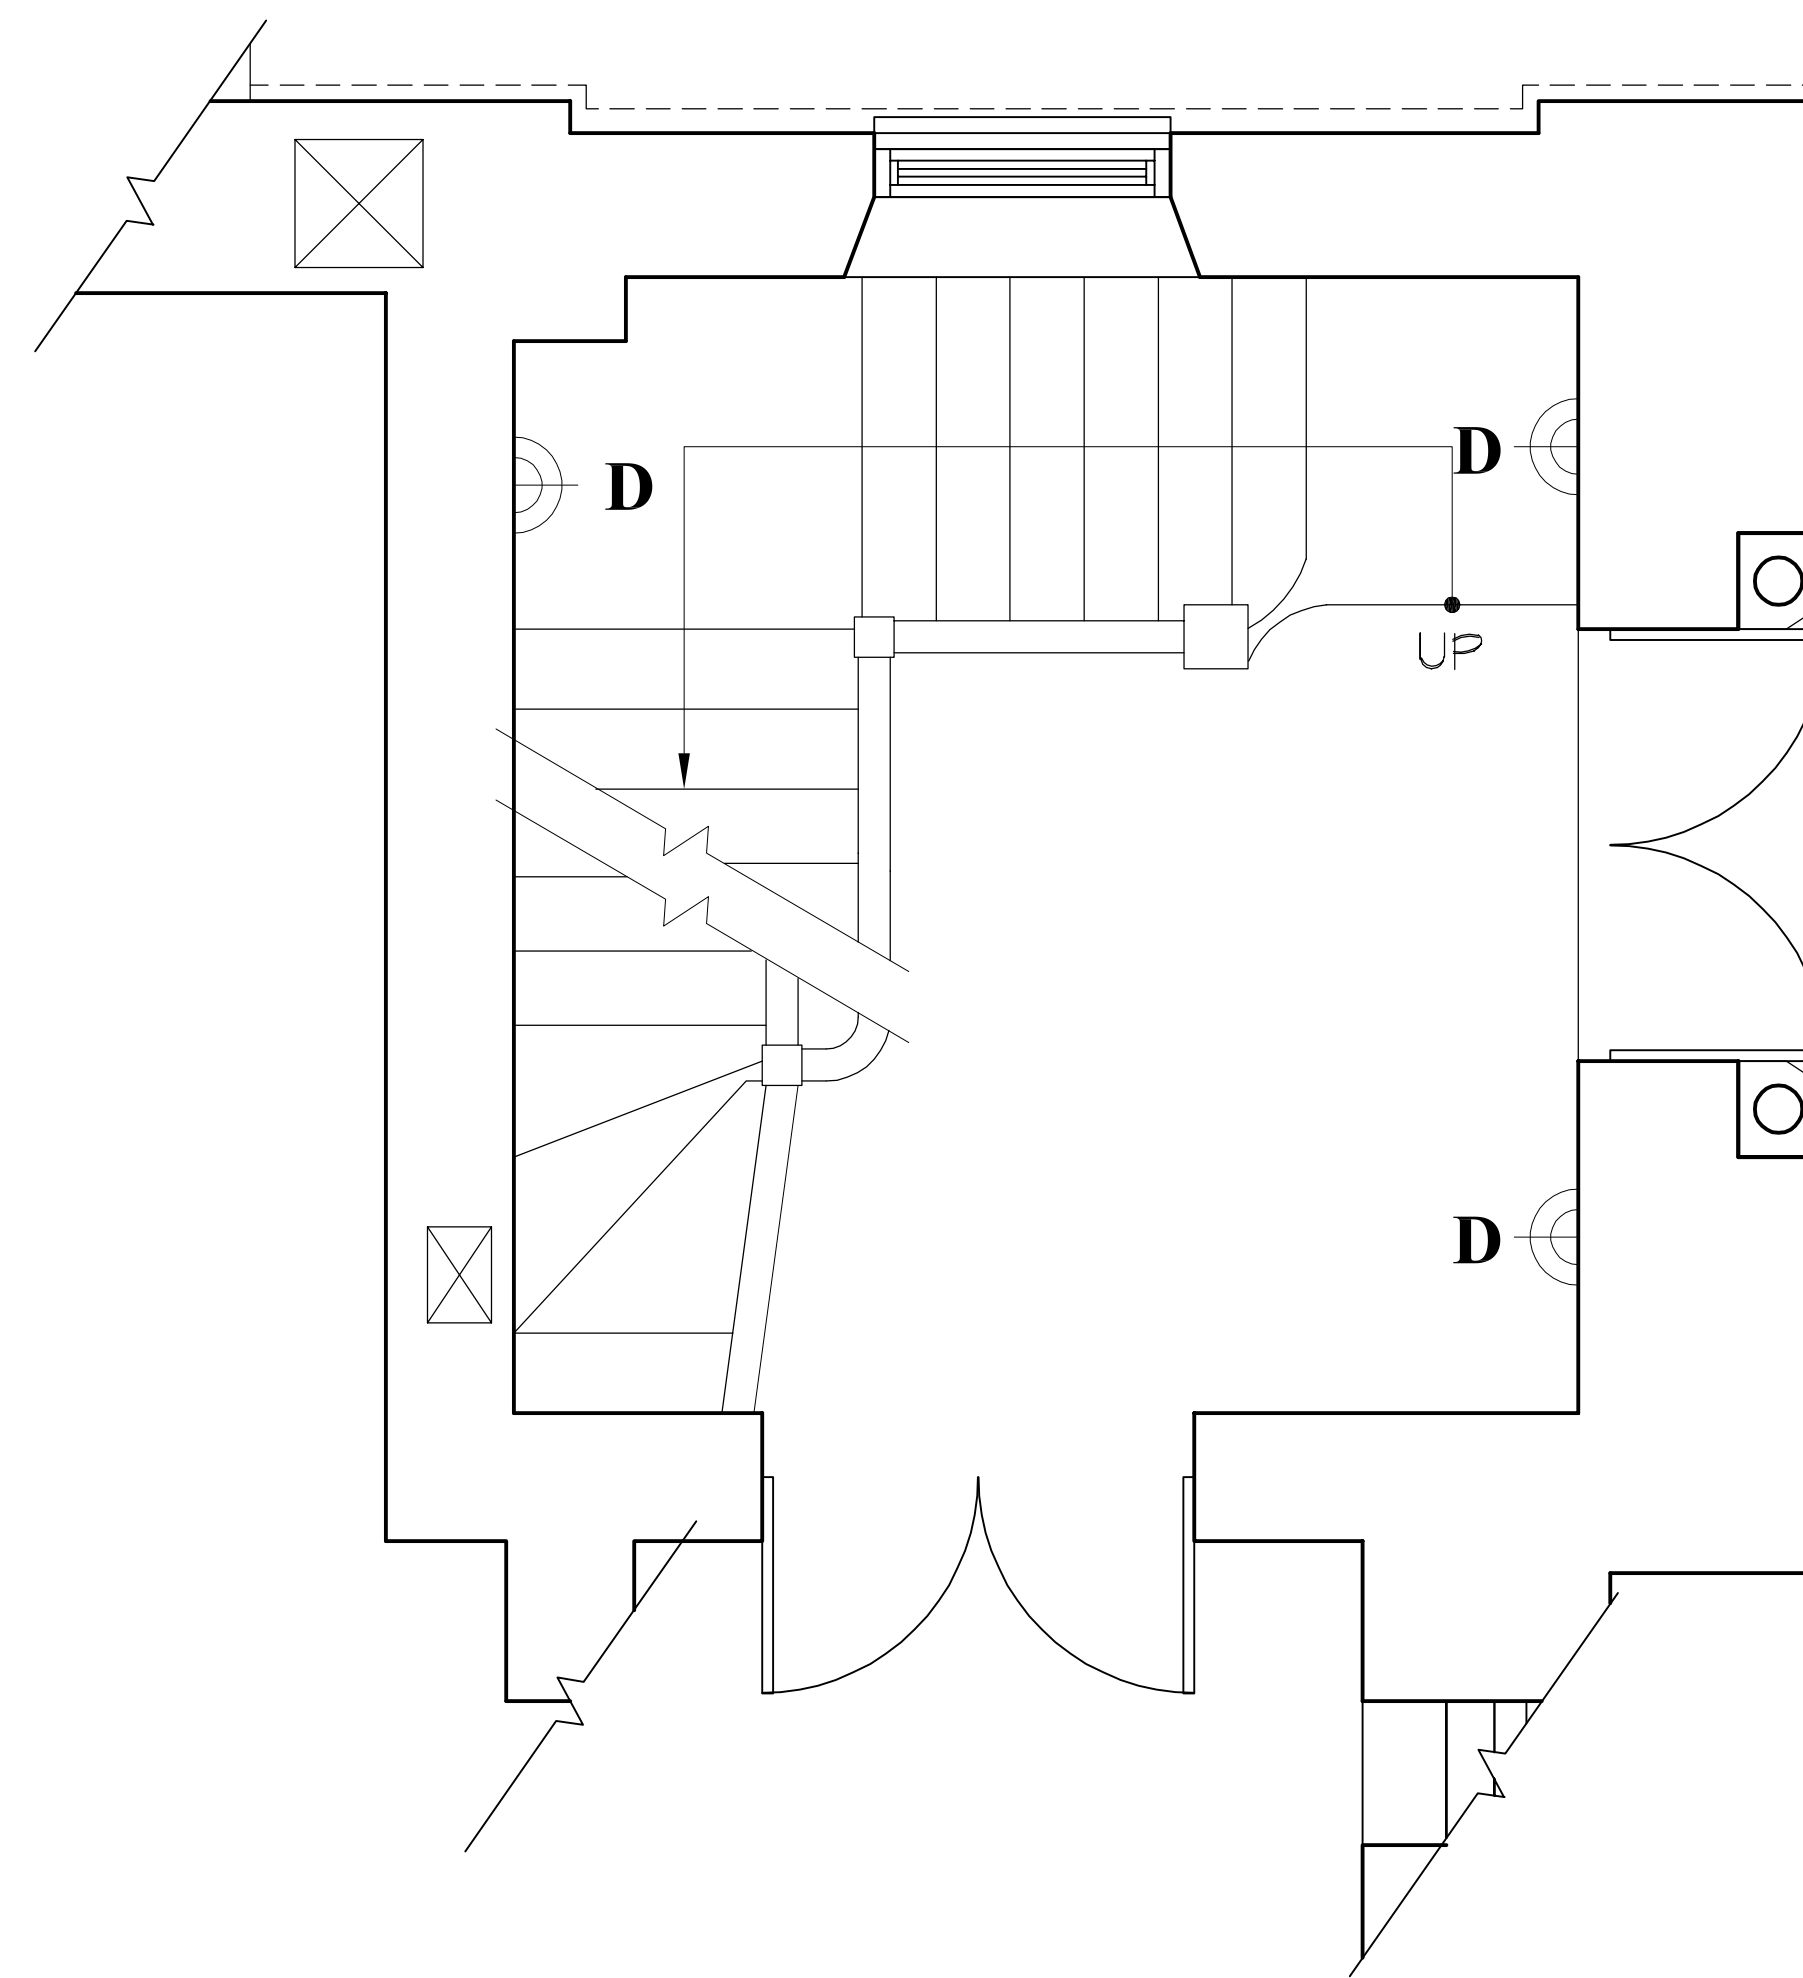


Stair Plan @ First Floor

SCALE:
1/2" = 1'-0" 2

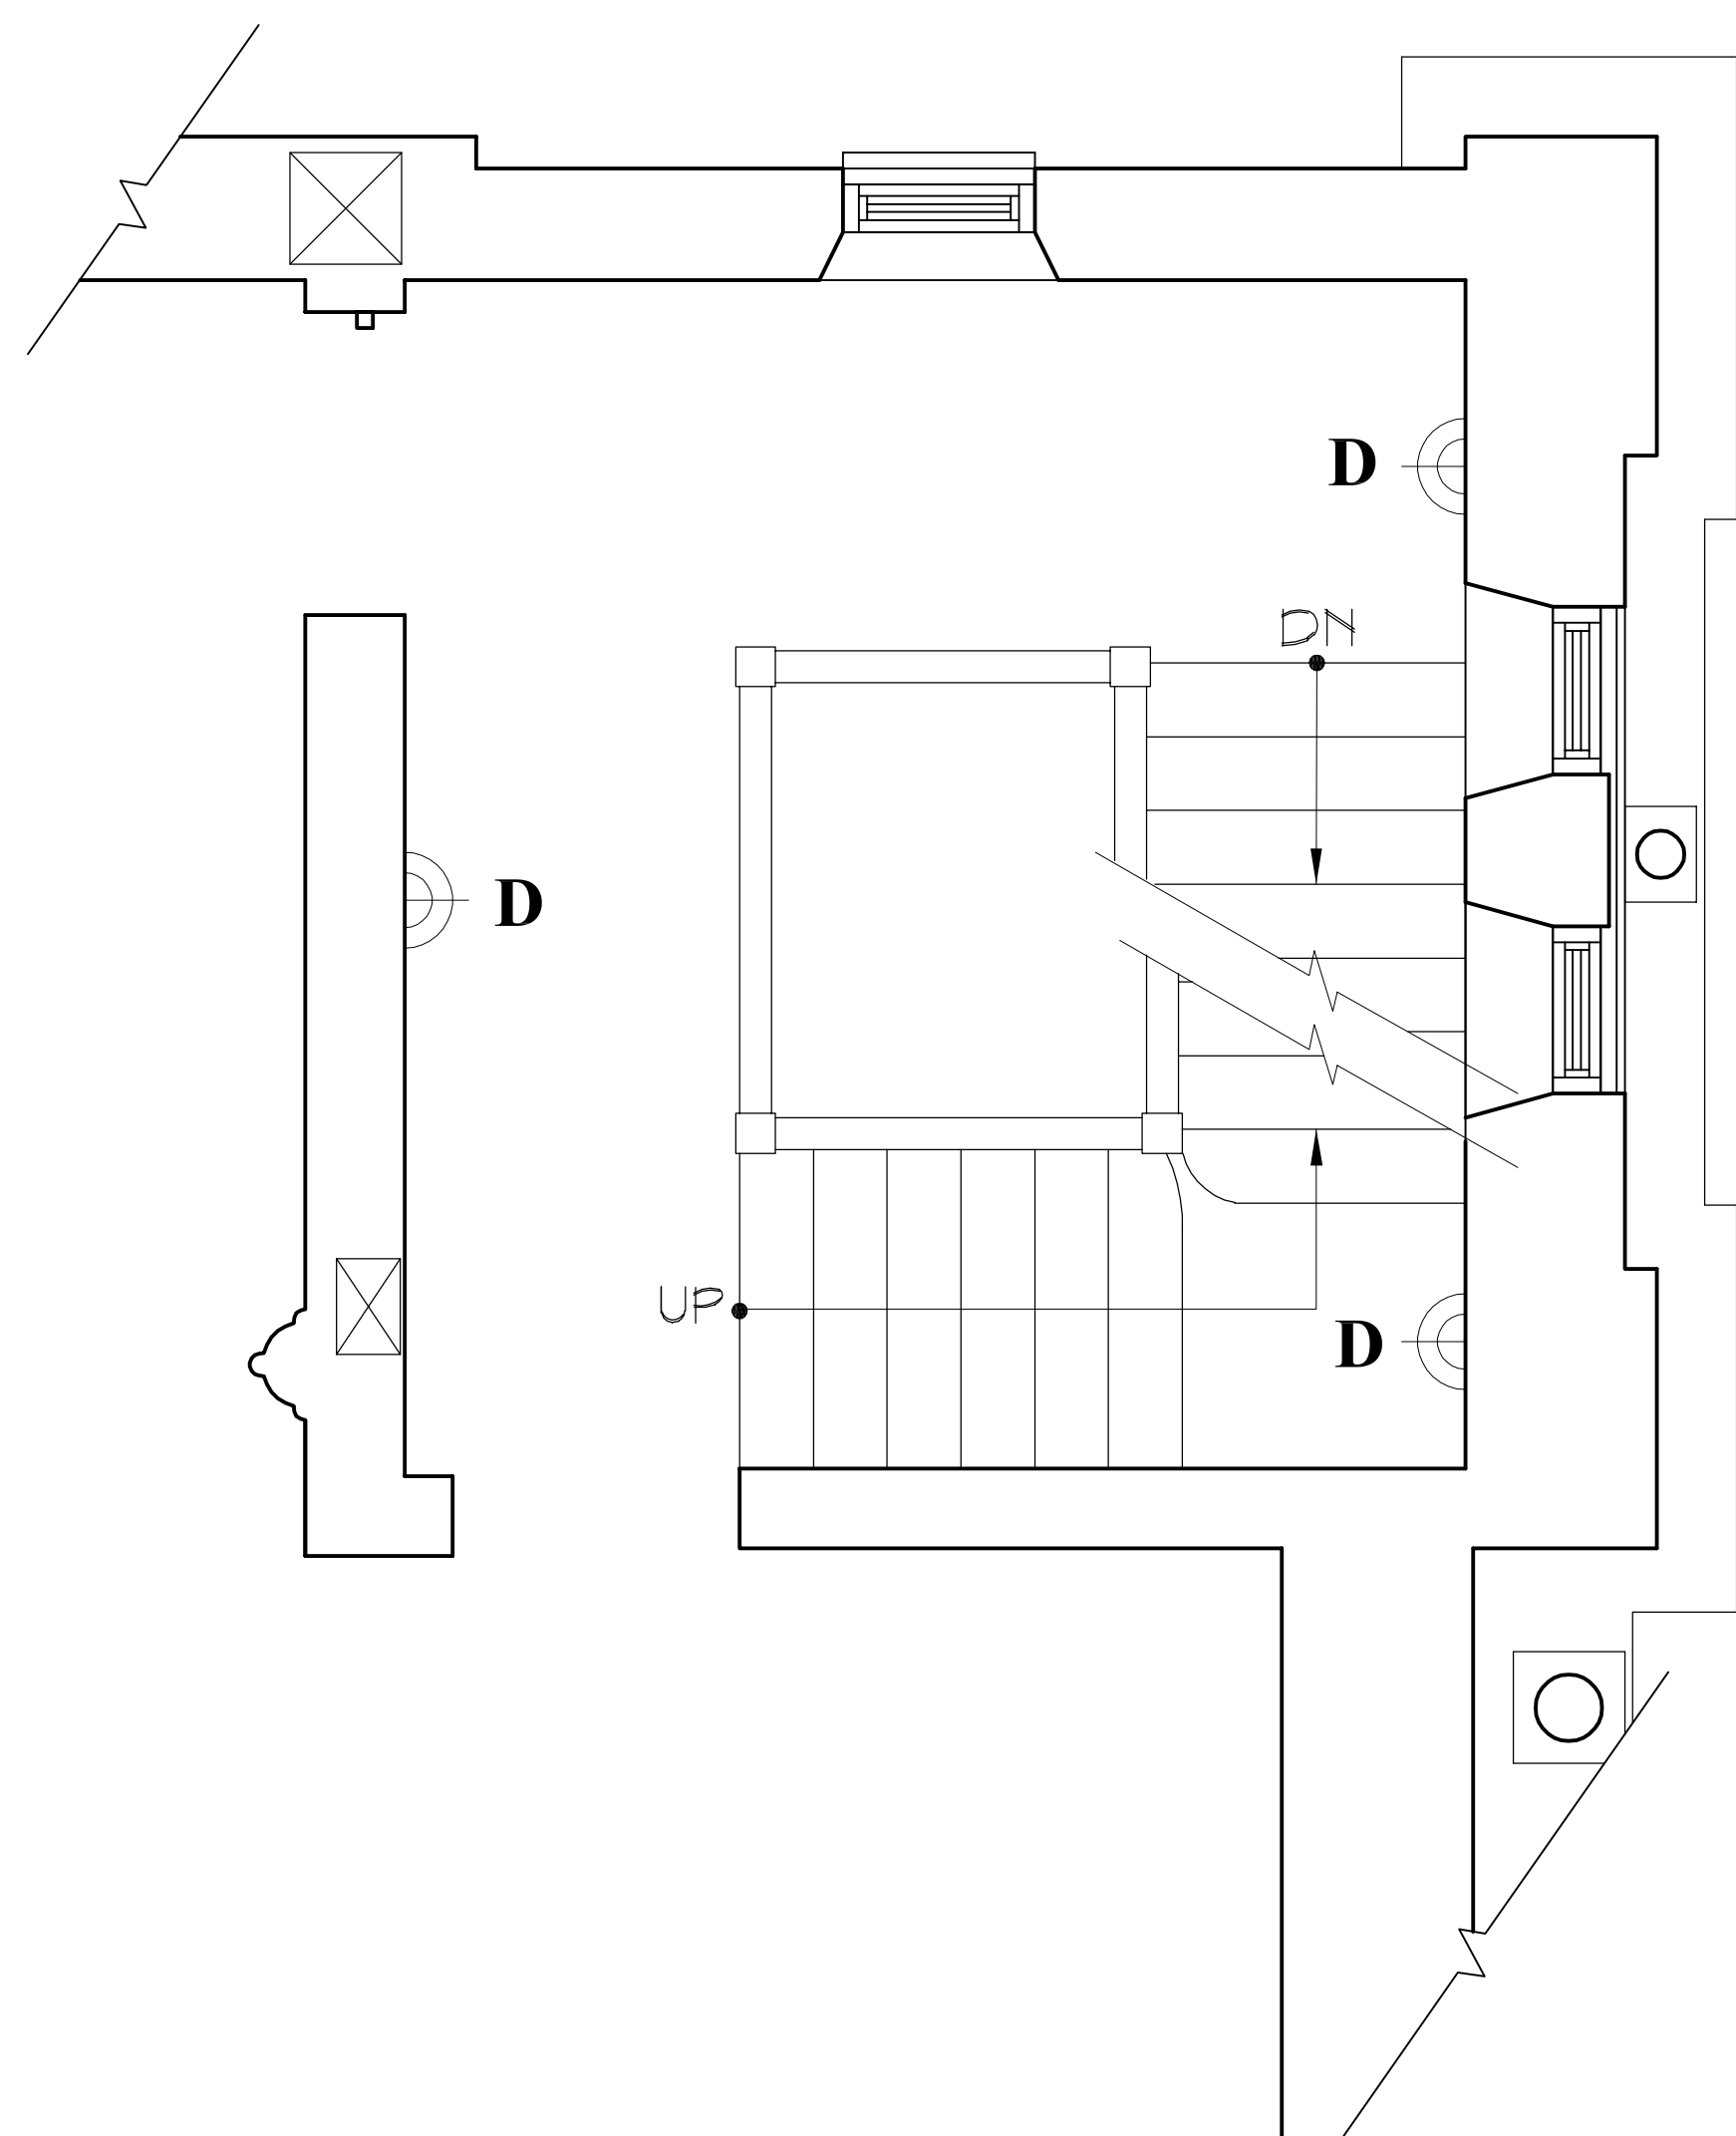

Stair Plan @ Balcony

SCALE:
1/2" = 1'-0" 3

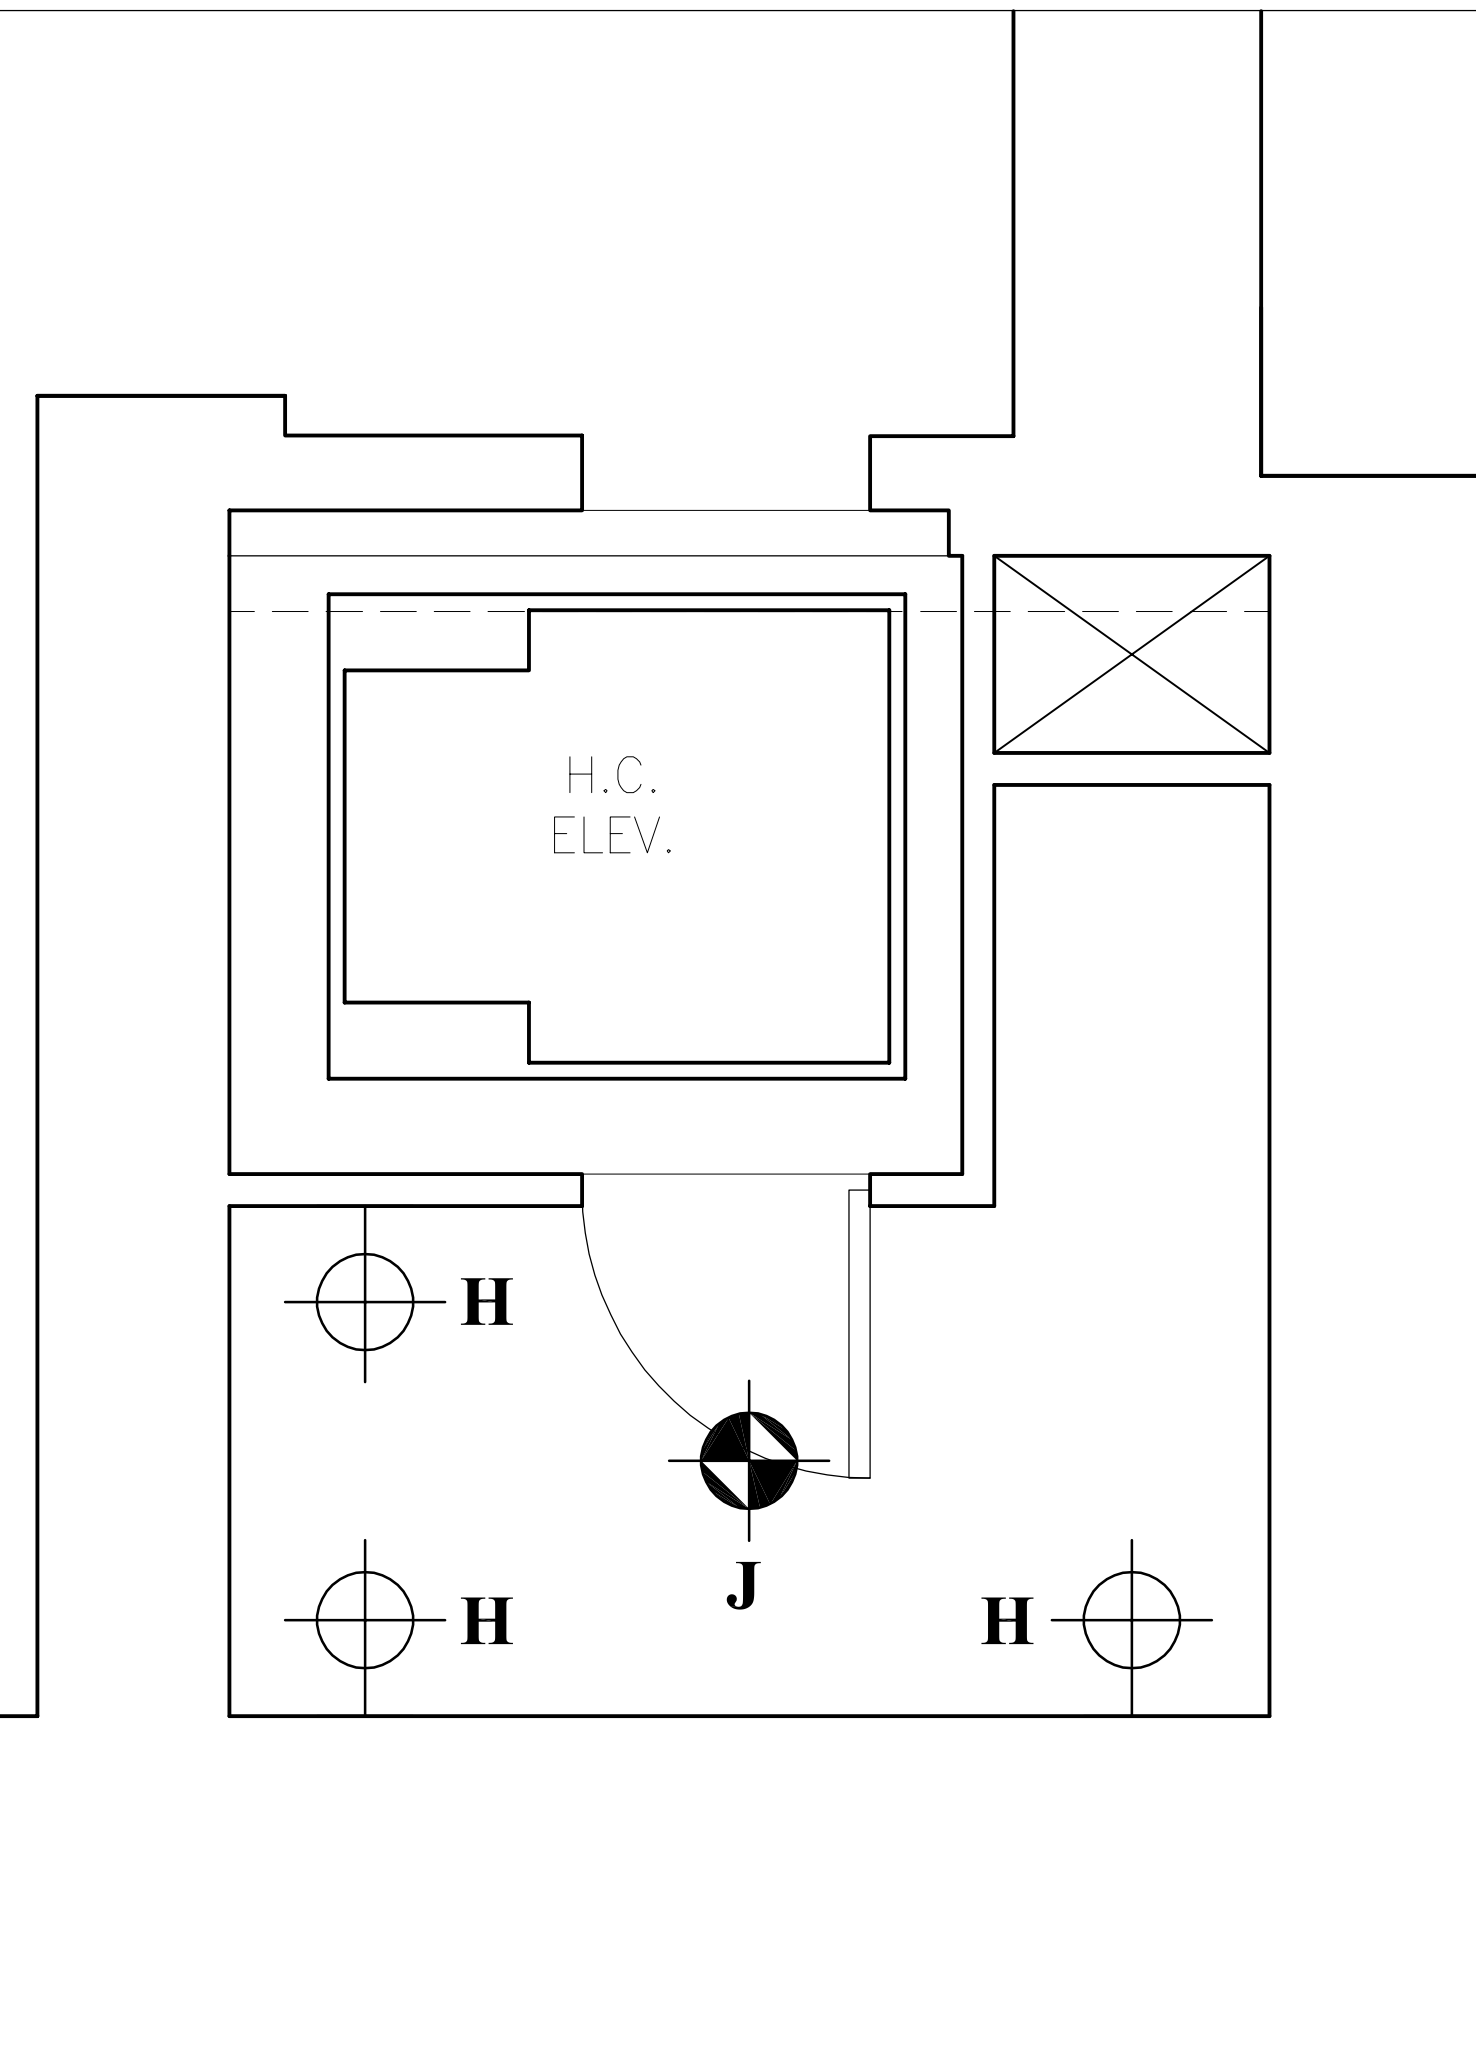


ADA Lobby North Tower

SCALE:
1/2" = 1'-0" 4

ISSUED FOR LMDC REVIEW 6/15/07
Issue/Revision Date

Date
June 15, 2007

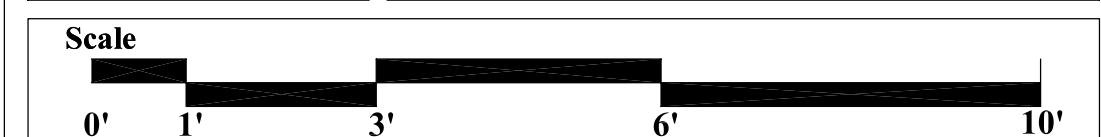

Sheet Title
Historic Stair Lighting Plans

Drawing No.
A-4