


Eldridge Street Synagogue

Interior Restoration Lighting

Eldridge Street Project
12 Eldridge Street
New York, NY 10002


ISSUED FOR BID

LIGHTING FIXTURE SCHEDULE (PURCHASED BY ELECTRICAL CONTRACTOR)							
DESIG.	SYMBOL	FIXTURE DESCRIPTION	MFG. / CAT. NO.	LAMPS	LOCATION	QUANTITY	NOTES
"A"	○	ETERNAL LIGHT BRASS BASKET FIXTURE AND BRACKET	AURORA LAMPWORKS, NO. 4	A LAMP 75 W	ARK MAIN FLOOR	1	GLASS SHADES BY OWNER http://www.auroralampworks.com/ 172 NORTH 11TH ST., BROOKLYN, NY 11211. TEL: (718) 384-6039, FAX: (718) 384-6198.
"B"	⌒	ORNAMENTAL THREE-ARMED ROUND BASKET AND CROWN BRASS FIXTURE	AURORA LAMPWORKS, 1-SERIES	A LAMP 75 W	10 MAIN FLOOR 8 BALCONY FLOOR	18	GLASS SHADES BY OWNER http://www.auroralampworks.com/ 172 NORTH 11TH ST., BROOKLYN, NY 11211. TEL: (718) 384-6039, FAX: (718) 384-6198.
"C"	⌒	BRASS HALF COLUMN RING FIXTURE	AURORA LAMPWORKS, 2-SERIES	A LAMP 75 W	2 MAIN FLOOR 2 BALCONY FLOOR	4	GLASS SHADES BY OWNER http://www.auroralampworks.com/ 172 NORTH 11TH ST., BROOKLYN, NY 11211. TEL: (718) 384-6039, FAX: (718) 384-6198.
"D"	⌒	TWO-ARM BRASS SCONCE	AURORA LAMPWORKS, 10-SERIES	A LAMP 75 W	1 MAIN FLOOR 2 BALCONY FLOOR 7 SOUTH TOWER STAIRS	10	GLASS SHADES BY OWNER http://www.auroralampworks.com/ 172 NORTH 11TH ST., BROOKLYN, NY 11211. TEL: (718) 384-6039, FAX: (718) 384-6198.
"E"	⌒	3-ARM BRASS SCONCE	AURORA LAMPWORKS, 11-SERIES	A LAMP 75 W	BALCONY FLOOR	6	GLASS SHADES BY OWNER http://www.auroralampworks.com/ 172 NORTH 11TH ST., BROOKLYN, NY 11211. TEL: (718) 384-6039, FAX: (718) 384-6198.
"F-1"	■	22" SLIMLINE PICTURE LIGHTS	HOUSE OF TROY, NO. XL22-61	T4	MAIN FLOOR	2	POLISHED BRASS FINISH http://www.houseoftroy.com/index.aspx 902 SILVER RIDGE ROAD, HYDE PARK, VT 05655. TEL: (800) 428-5367, FAX: (888) 881-7952.
"F-2"	⊞	36" DIRECT WIRE PICTURE LIGHT WITH SATIONARY HORIZONTAL ARM EXTENSION	HOUSE OF TROY, NO. DSL36	T4	MAIN FLOOR	4	SATIN BRASS FINISH http://www.houseoftroy.com/index.aspx 902 SILVER RIDGE ROAD, HYDE PARK, VT 05655. TEL: (800) 428-5367, FAX: (888) 881-7952.
"G"	⊕	BRASS CANOPY WITH HANG STRAIGHT FIXTURE WITH ART GLASS 4" AURENE TEARDROP SHADE	BASE: REMAINS LIGHTING, NO. HL0650F SHADE: REJUVENATION, NO. BC4501	60 W	MAIN FLOOR UNDER BALCONY	20	http://remains.com/index.aspx 130 WEST 28TH STREET NEW YORK, NY 10001 TEL: (212) 675-8051, FAX: (212) 675-8052 http://www.rejuvenation.com/550 NW NICOLA STREET PORTLAND, OR 97210 TEL: (888) 401-1900, FAX: (800) 526-7329
"H"	⊕	1'-0" ADA WALL SCONCE	FOCAL POINT, METRO SERIES, NO. FMEC-1	T5	ADA LOBBY NORTH TOWER	3	http://www.focalpointlights.com/defaultx.htm 4201 S. PULASKI ROAD, CHICAGO, IL 60632. TEL: (773) 247-9494, FAX: (773) 247-8484.
"I-1"	⊕	WALL MOUNTED 48" STEM SINGLE SIGN LIGHT	WINONA LIGHTING, WINDSCAPE, PLACER SERIES LAMP: COLOR KINETICS, IWMR SERIES	IWMR	EXTERIOR	5	MODIFICATION LED MR LAMPS http://www.winonalighting.com/winscape 3760 WEST FOURTH STREET, WINONA, MN 55987. TEL: (800) 328-5291, FAX: (507) 454-1814.
"I-2"	⊕	WALL MOUNTED 48" STEM DUAL SIGN LIGHT WITH LINEAR ACCESSORY LENS	FIXTURE: WINONA LIGHTING WINDSCAPE, PLACER TWIN SERIES LAMP: COLOR KINETICS, IWMR SERIES	IWMR	EXTERIOR	12	MODIFICATION LED MR LAMPS http://www.winonalighting.com/winscape 3760 WEST FOURTH STREET, WINONA, MN 55987. TEL: (800) 328-5291, FAX: (507) 454-1814.
"J"	●	24" DIAMETER CEILING MOUNTED LIGHT	DELUX CUSTOM LIGHTING INC. NO. SM 9034	6-26 W CFL	ADA LOBBY NORTH TOWER	1	http://www.deluxcustomlighting.com/index.asp 5918 CLARA STREET, BELL GARDENS, CA 90201. TEL: (562) 806-9671, FAX: (562) 806-3581.
"K"	⊕	ELLIPTICAL REFLECTOR FLOODLIGHT ON A 6" CANOPY	TIMES SQUARE LIGHTING FIXTURE: NO. 154 BASE: NO. CM4	1,000 W IF	BALCONY FLOOR	6	http://www.tsilight.com/ 5 KAY FRIES DRIVE, STONY POINT, NY 10980 TEL: (845) 947-3034, FAX: (845) 947-3047
"L"	⊕	OPEN REFLECTOR LIGHTING FIXTURE WITH CLAMP	TIMES SQUARE LIGHTING, FIXTURE: SOURCE FOUR, NO. PAR-EA CLAMP: NO. CELL 208	HPL COMPACT TUNGSTEN 750 W	BALCONY FLOOR	12	ON ARMATURE (SEE DETAIL) http://www.tsilight.com/ 5 KAY FRIES DRIVE, STONY POINT, NY 10980 TEL: (845) 947-3034, FAX: (845) 947-3047

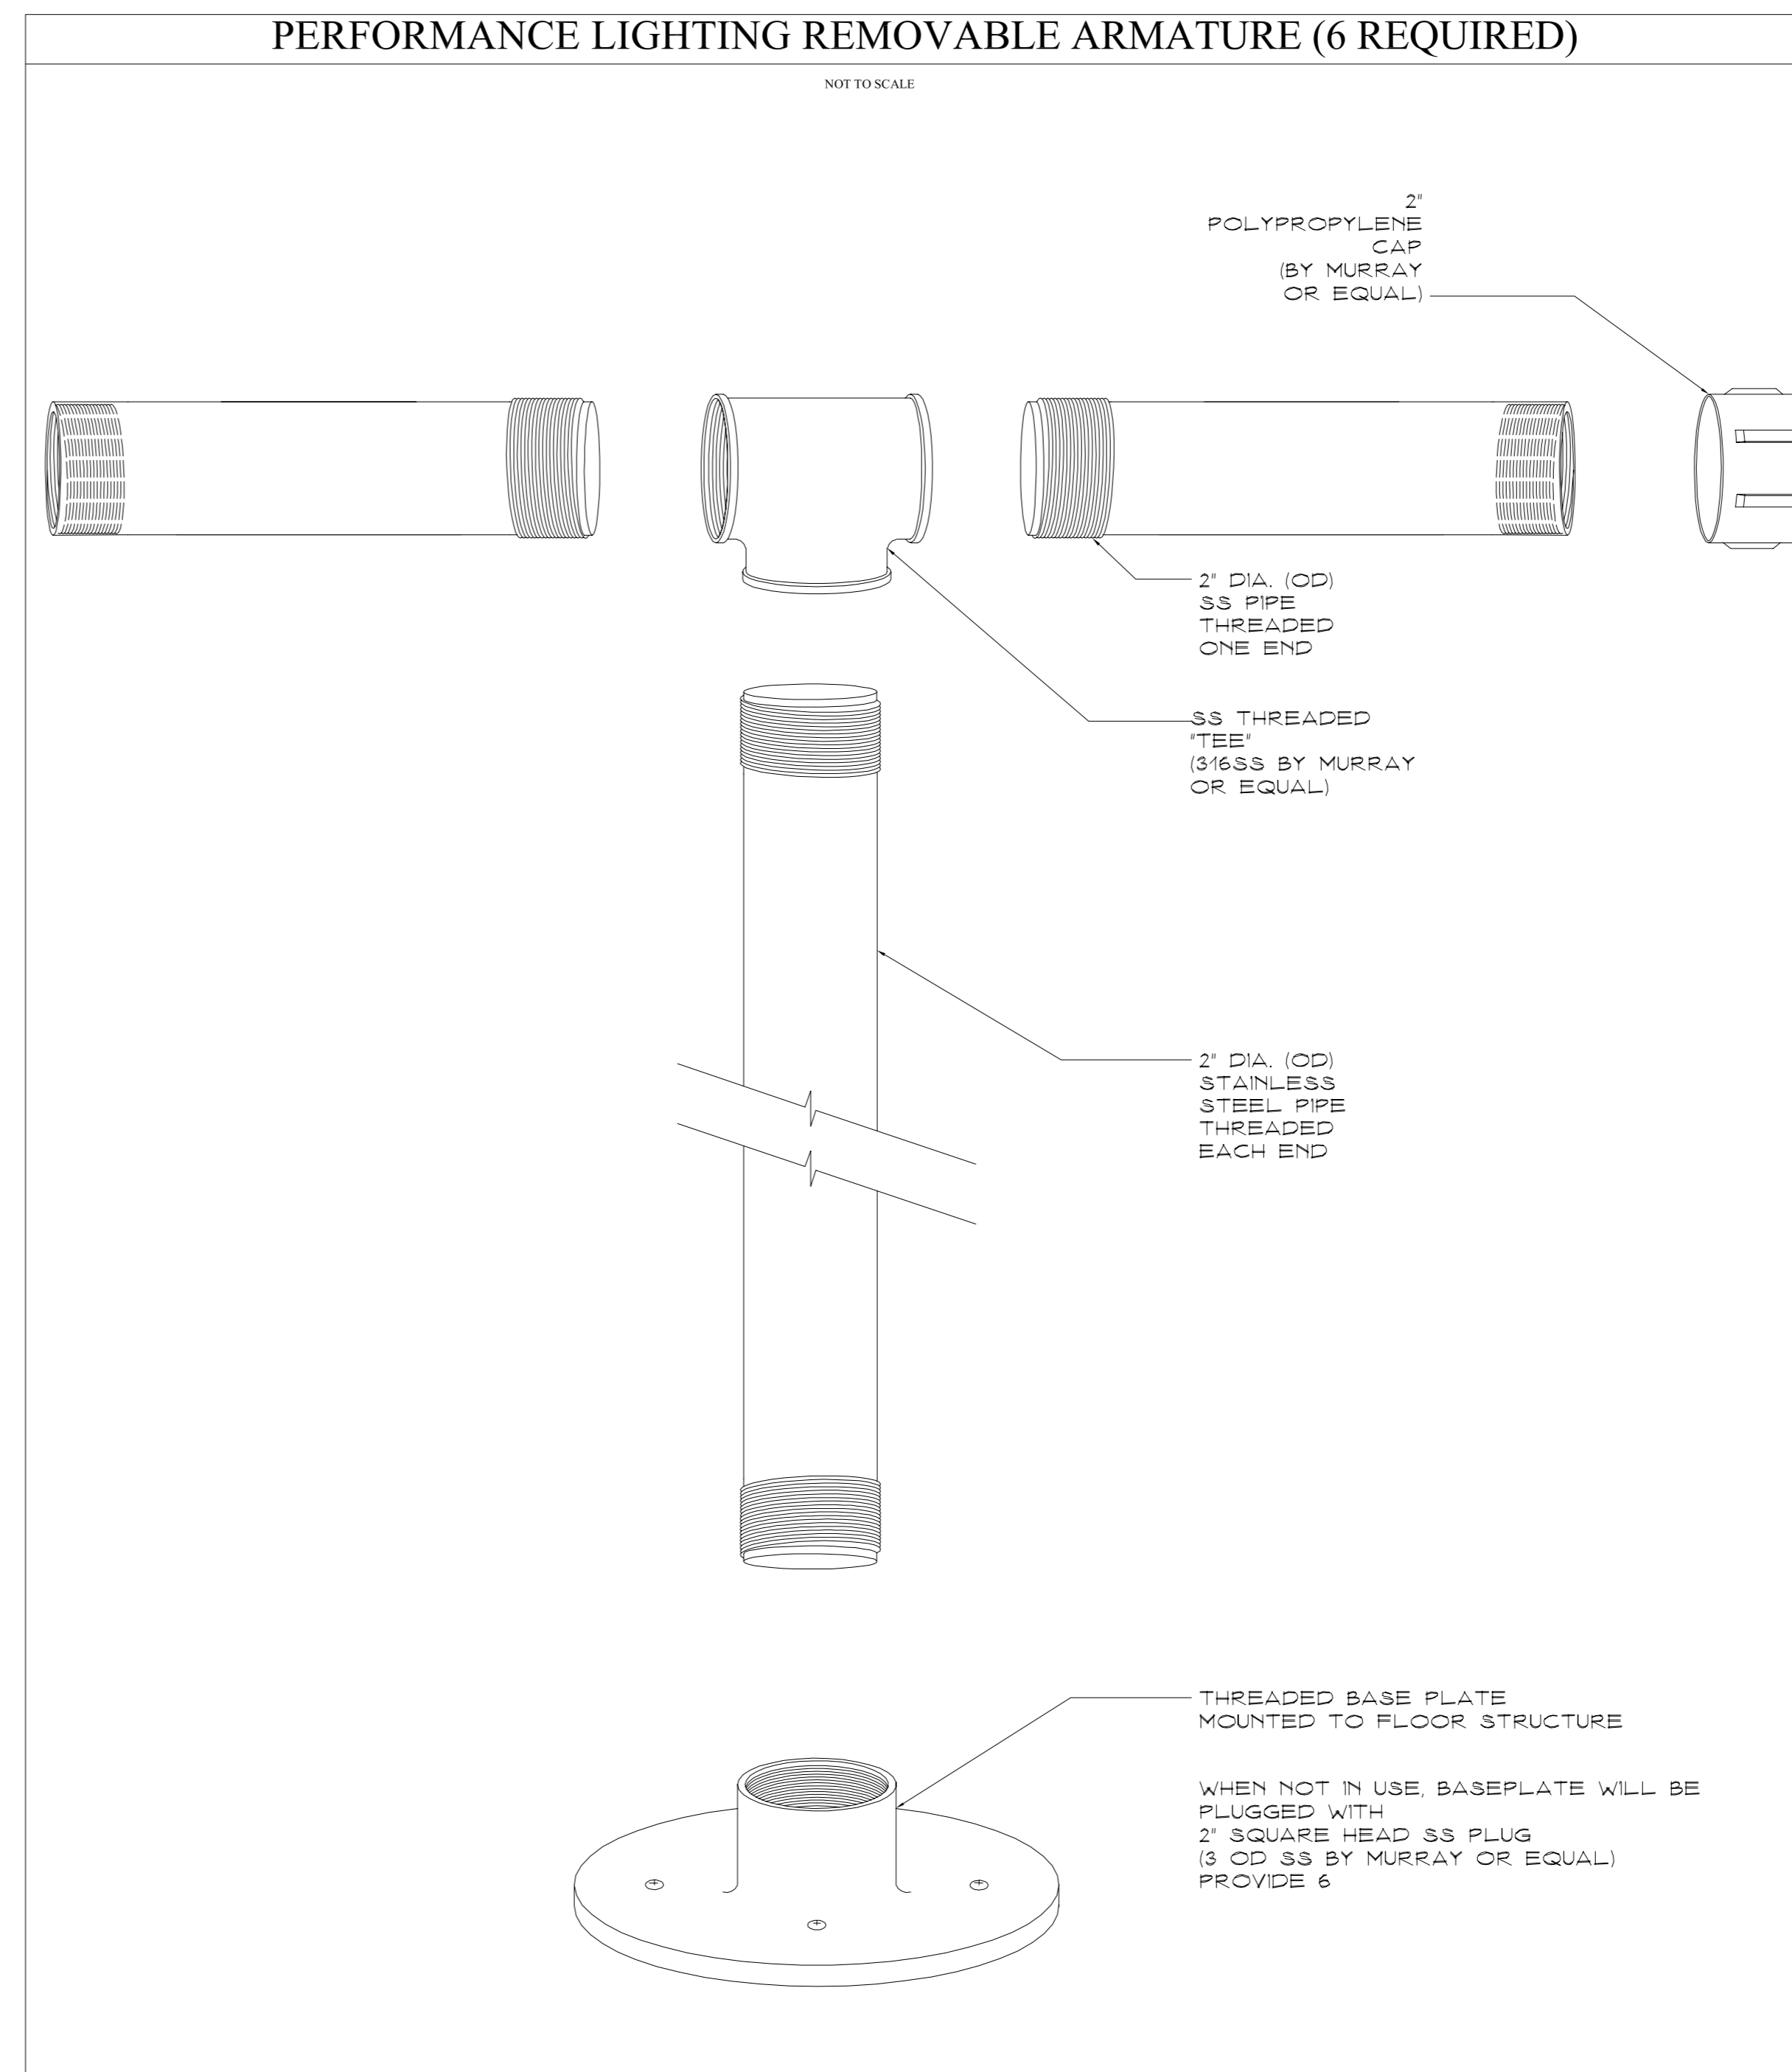

ISSUED FOR LMDC REVIEW 6/15/07
Issue/Revision Date

Date **June 15, 2007**

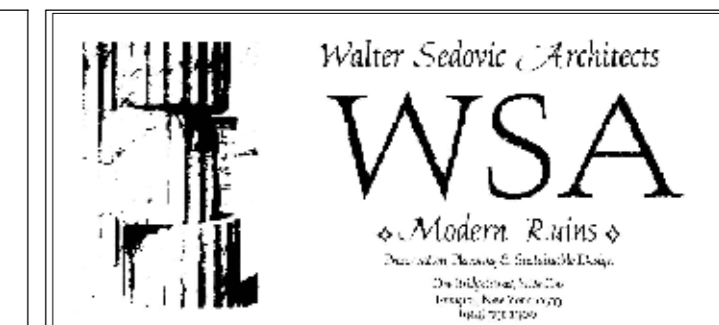

Scale **As Noted**

Sheet Title **Lighting Schedule** Drawing No. **A-5**