


Eldridge Street  
Synagogue

Interior Restoration  
Lighting

Eldridge Street Project  
12 Eldridge Street  
New York, NY 10002

ISSUED FOR BID

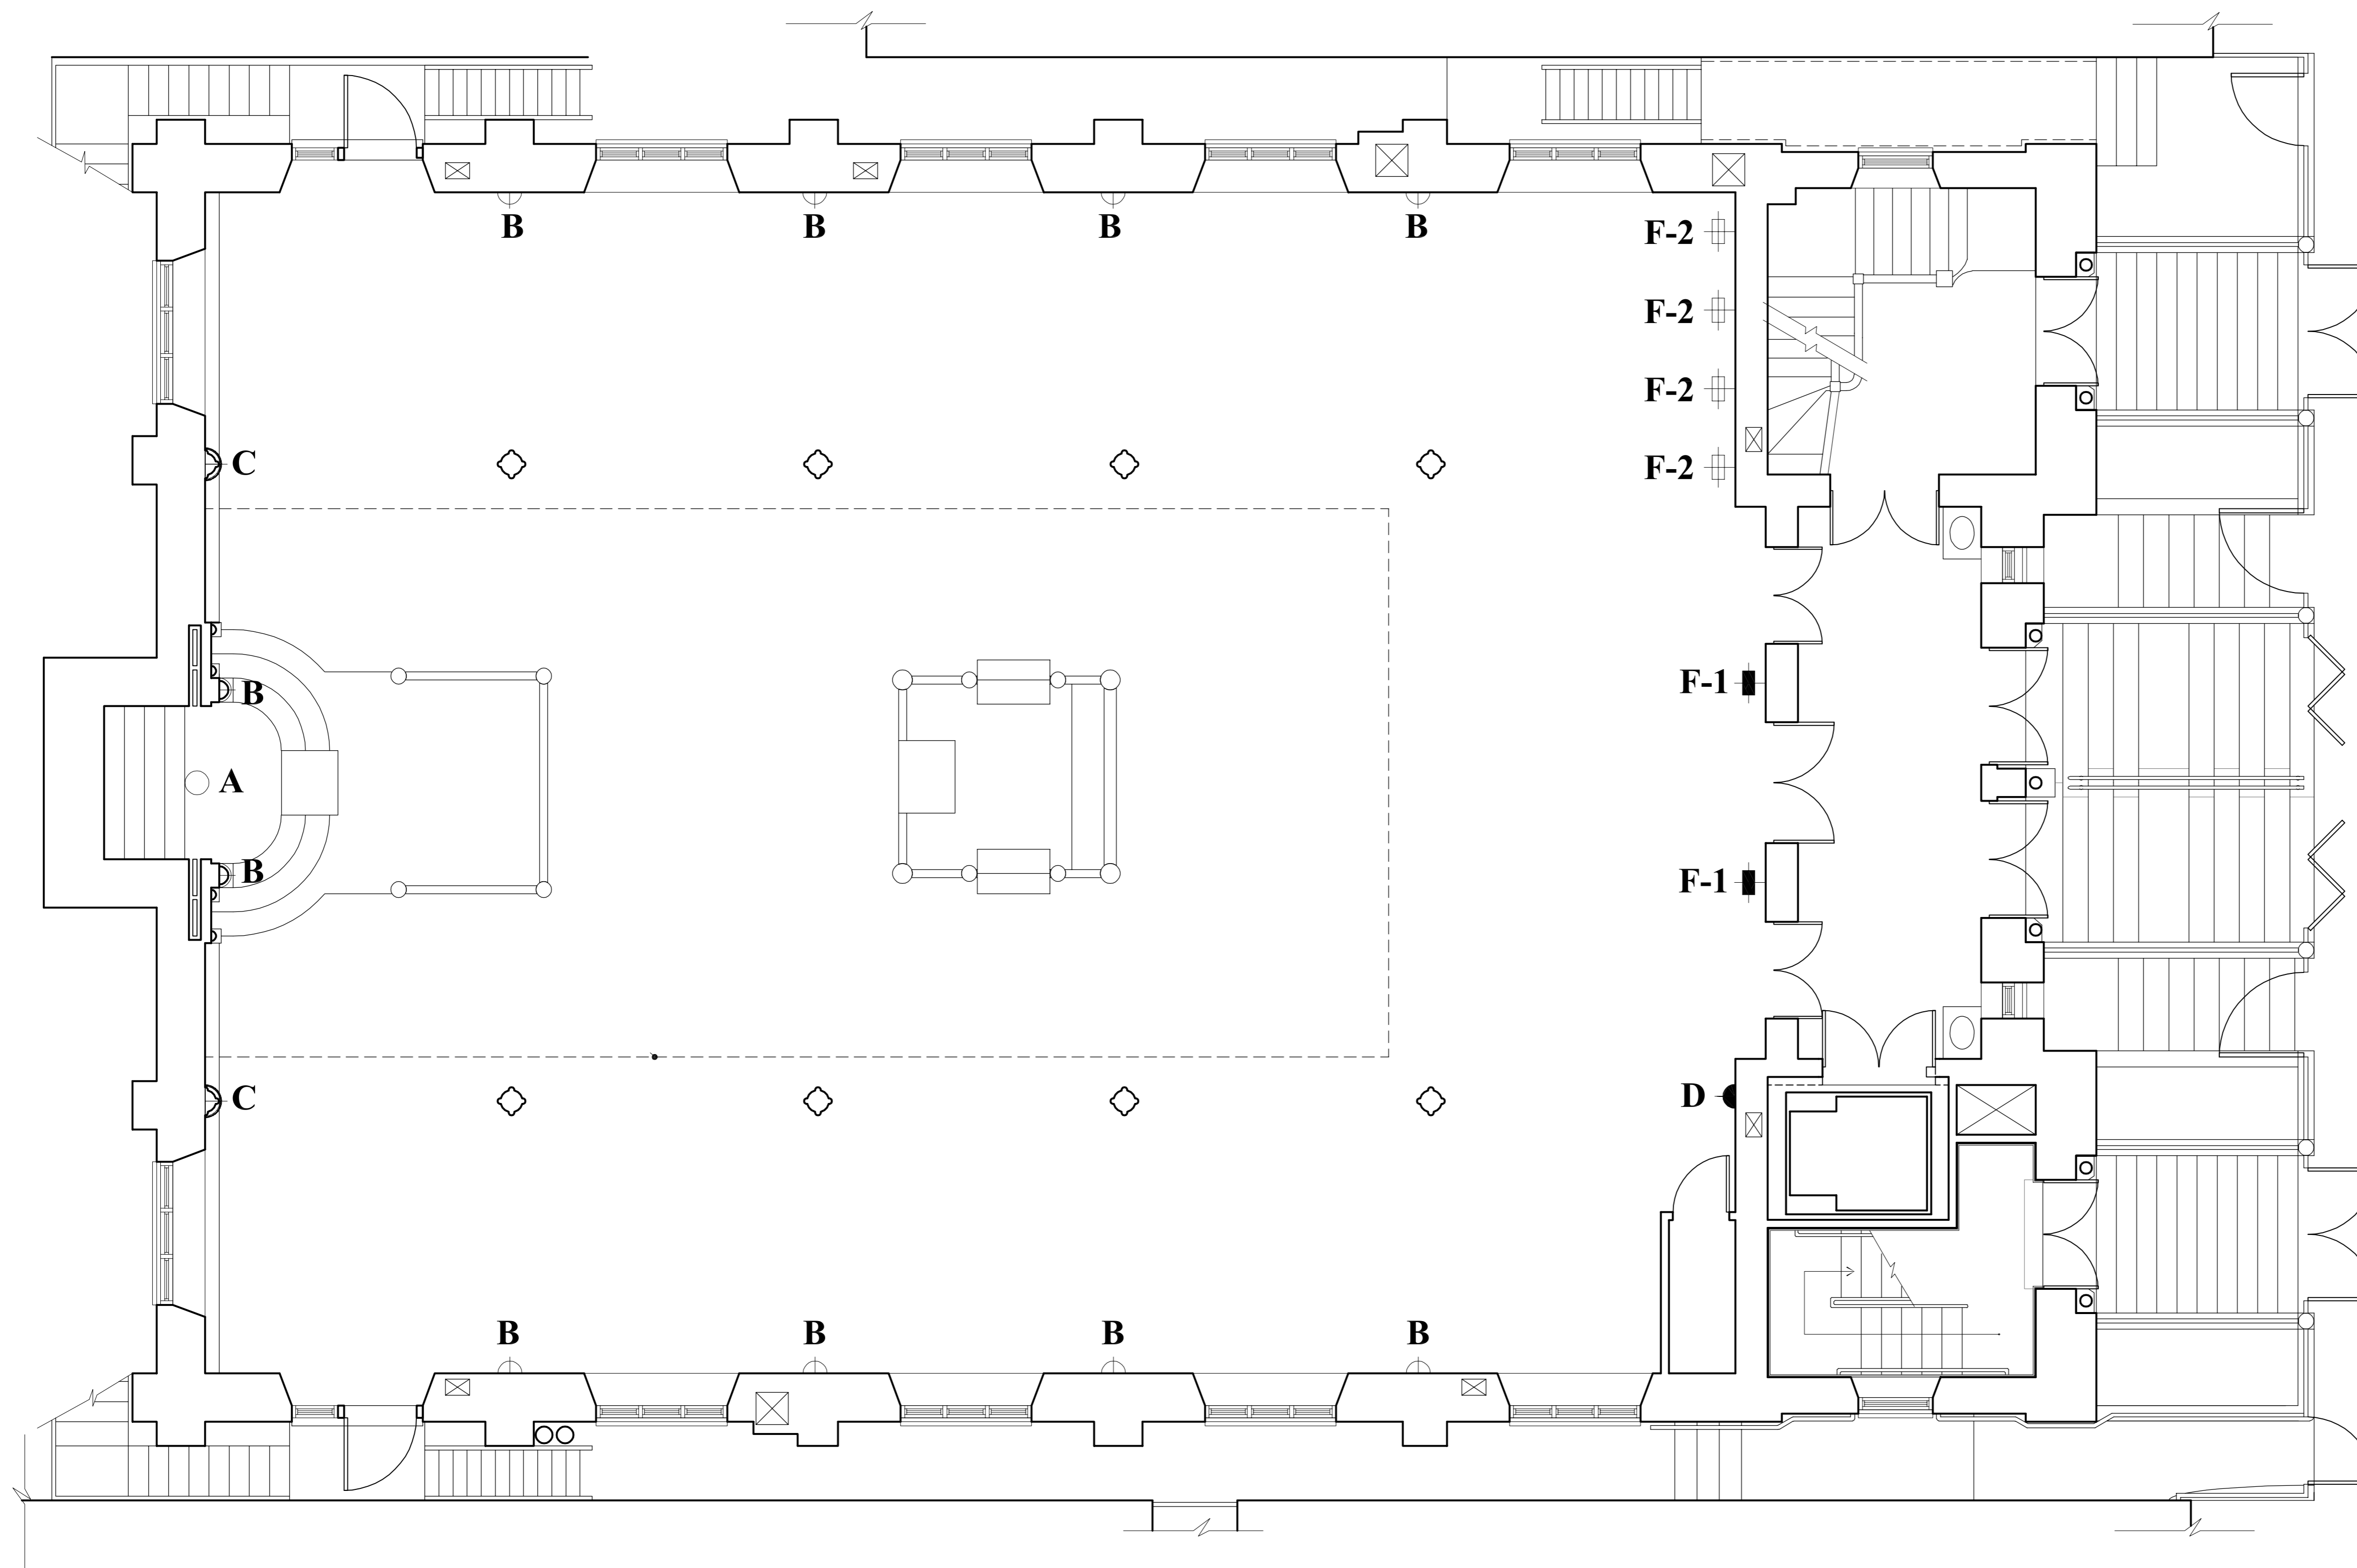

ISSUED FOR LMDC REVIEW 6/15/07  
Issue/Revision Date

Date  
**June 15, 2007**



Scale  
0' 1' 3' 6' 12'

Sheet Title  
**Main Floor Lighting Plan**

Drawing No.  
**A-1**