


# Eldridge Street Synagogue

## Interior Restoration Lighting


Eldridge Street Project  
12 Eldridge Street  
New York, NY 10002

ISSUED FOR BID

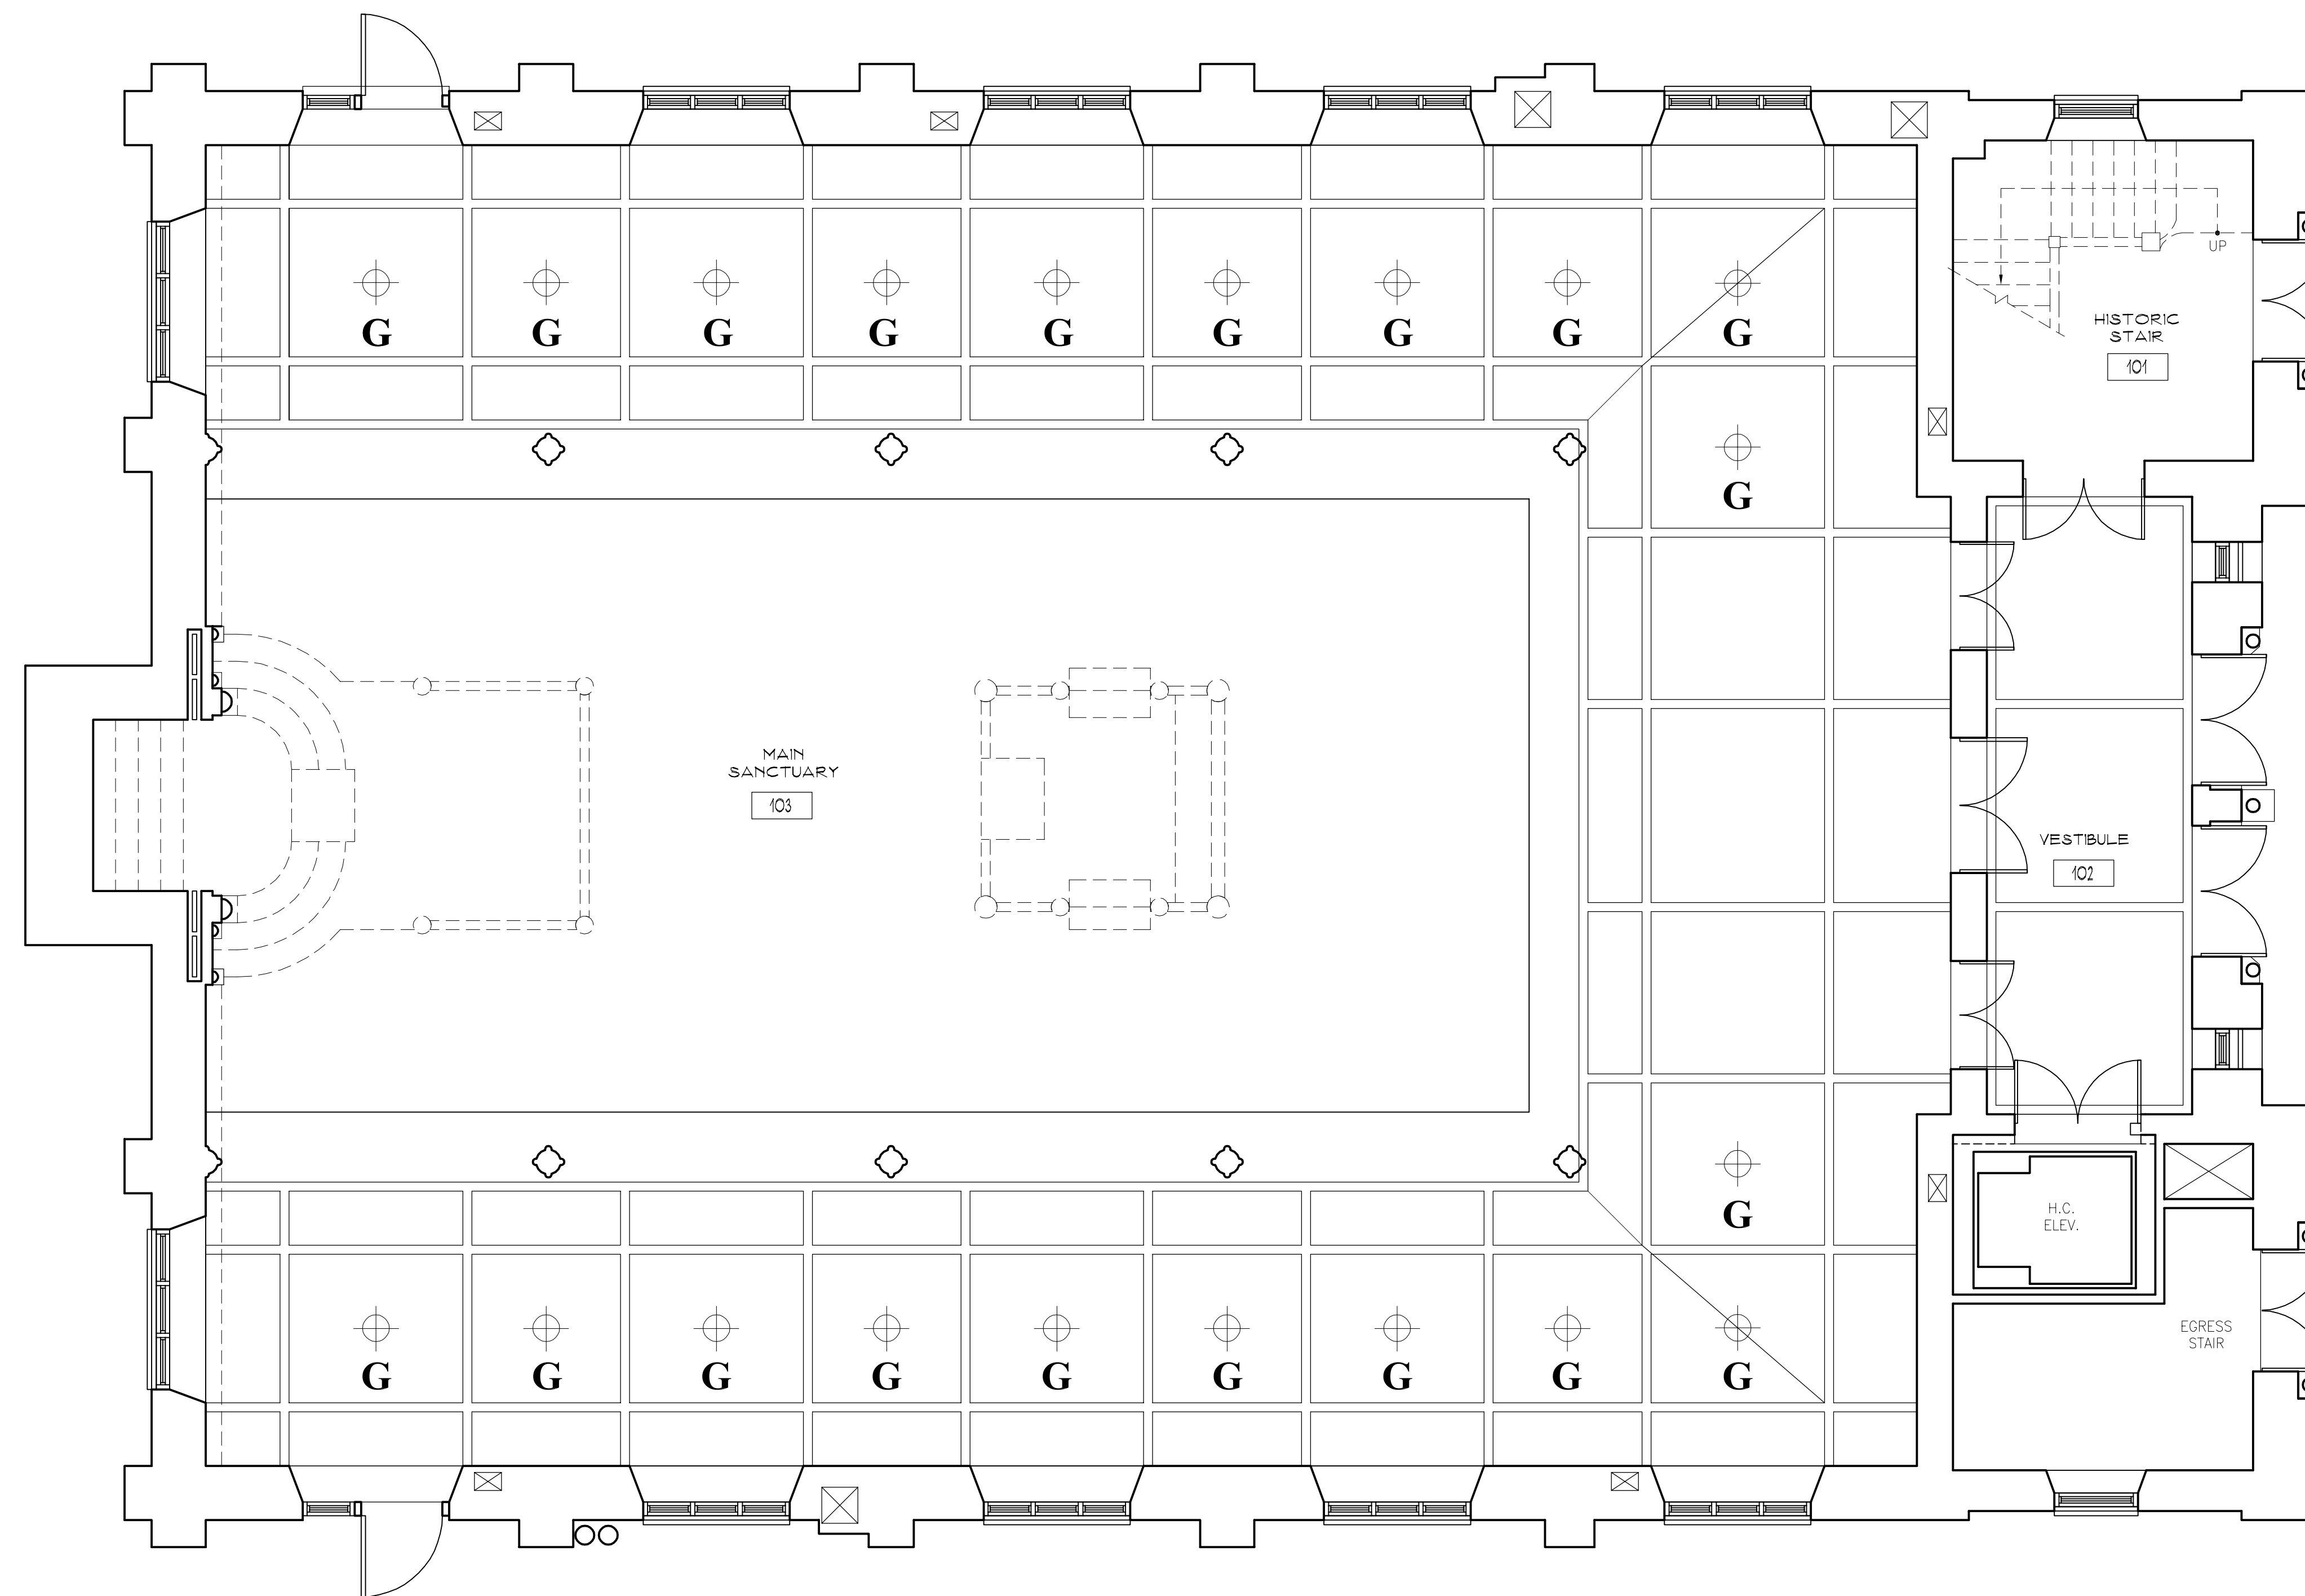

ISSUED FOR LMDC REVIEW 6/15/07  
Issue/Revision Date

Date **June 15, 2007**

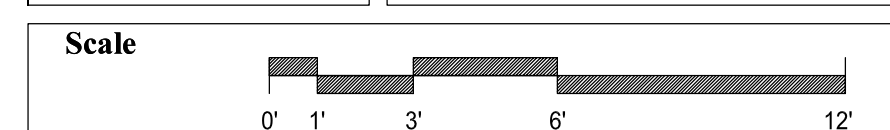

Sheet Title **Main Floor Ceiling Lighting Plan**

Drawing No. **A-3**