




NOTES: 1. CONCRETE AND REBAR SHALL BE PROVIDED FOR ALL PUMPS ABOVE LISTED.
2. REFER TO DRAWING 'MECHANICAL SYSTEMS' FOR PUMP SCHEDULE.

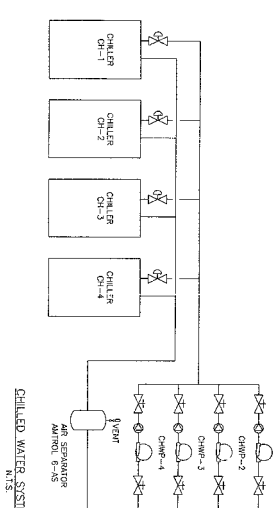


CHILLED WATER SYSTEM DIAGRAM
NOT TO SCALE

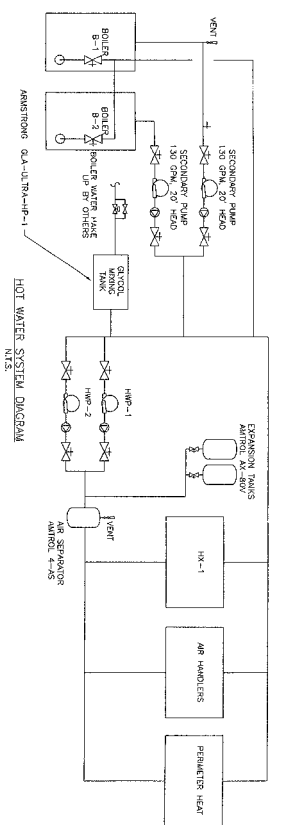


HOT WATER SYSTEM DIAGRAM
NOT TO SCALE

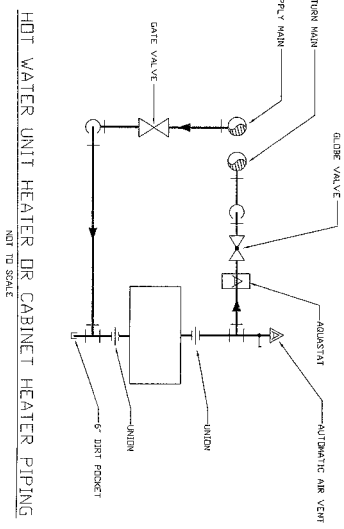


HOT WATER UNIT HEATER OR CABINET HEATER PIPING
NOT TO SCALE

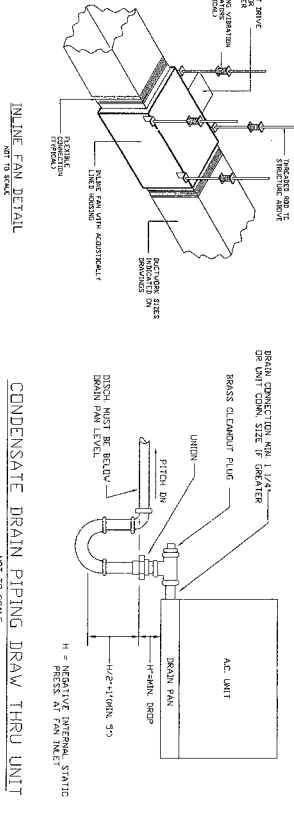


CONDENSATE DRAIN PIPING THRU UNIT
NOT TO SCALE

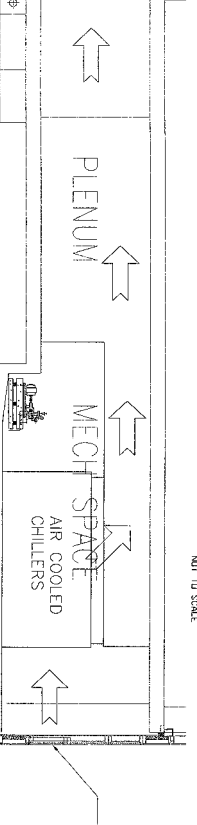


INLINE FAN DETAIL
NOT TO SCALE

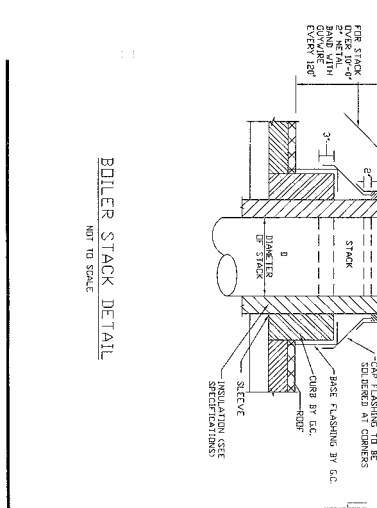

BOILER STACK DETAIL
NOT TO SCALE

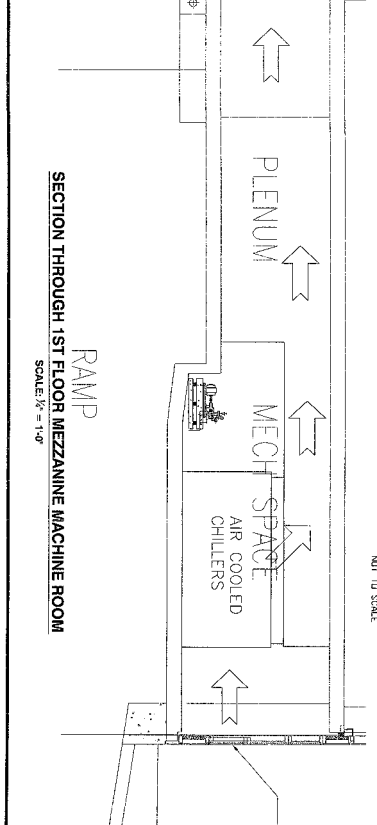

SECTION THROUGH 1ST FLOOR MEZZANINE MACHINE ROOM
SCALE: 1/8" = 1'-0"

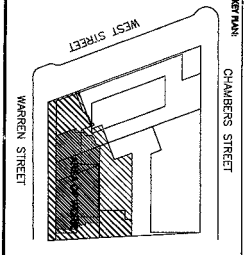

MANCINI DUFFY ARCHITECTURE DESIGN

300 CHAMBERS ST
F 512.786.1104

History, Architecture & Interiors, Inc. Architects
39 West 13th Street, New York, NY 10011
Tel: 212.928.1240 Fax: 212.928.1247
E-Mail: mancini@mancini.com

M-E Engineers
1170th Avenue
New York, NY 10019
Tel: (212) 465-0700 Fax: (212) 465-4605

GENERAL NOTES:
1. CONTRACTOR SHALL REFER TO EXISTING CONDITION (BASE BUILDING DRAWINGS FOR LOCATION OF EXISTING PIPING, FANS, CONDUIT, AND FOR ADDITIONAL INFORMATION.)

NO.	DATE / REVISION	BY	CHK
1	12/15/09	MANCINI	DUFFY
2	12/15/09	MANCINI	DUFFY
3	12/15/09	MANCINI	DUFFY
4	12/15/09	MANCINI	DUFFY
5	12/15/09	MANCINI	DUFFY

SCALE: 1/8" = 1'-0"

PROJECT NUMBER: 02-2167-0100

DRAWING TITLE: MECHANICAL DETAILS

DRAWING NUMBER: M-111